

THIS DRAWING IS THE PROPERTY OF
 PINEWOOD GROUP LTD AND MUST NOT BE
 COPIED OR REPRODUCED IN WHOLE OR IN
 PART, BY ANY METHOD WHATSOEVER,
 WITHOUT PERMISSION OR THE WRITTEN
 AUTHORISATION OF PINEWOOD GROUP LTD


ALL DIMENSIONS TO BE CHECKED ON SITE
 PRIOR TO ANY COMMENCEMENT OF WORKS



PINEWOOD STUDIOS SITE PLAN

KEY:

[Symbol]	QUANTITY REQUIRED SINGLE TUBE LIFT OFF TIME
[Symbol]	QUANTITY REQUIRED TRIPLE TUBE LIFT OFF TIME
[Symbol]	LOW LEVEL, DIMMING SINGLE TUBE LIFT OFF TIME
[Symbol]	LOW LEVEL, DIMMING TRIPLE TUBE LIFT OFF TIME
[Symbol]	HIGH LEVEL, DIMMING SINGLE TUBE LIFT OFF TIME
[Symbol]	HIGH LEVEL, DIMMING TRIPLE TUBE LIFT OFF TIME
[Symbol]	HIGH LEVEL STAGE LIGHTING
[Symbol]	HIGH BAY LIGHT BARS
[Symbol]	QUANTITY REQUIRED COLLIM LIGHT
[Symbol]	QUANTITY REQUIRED WALL LIGHT
[Symbol]	LOW VOLT TRUSS DIMMING/STAGE
[Symbol]	PROCESSED COLLIM LIGHT
[Symbol]	BEAM CIRCLES AND BEAM UP LIGHTS
[Symbol]	EXISTING INDENTATIONS
[Symbol]	SHIELD POWER SOCKET
[Symbol]	SHIELD POWER SOCKET
[Symbol]	LOBBY SERVICE
[Symbol]	SHIELD DATA SOCKET
[Symbol]	SHIELD DATA SOCKET
[Symbol]	SHIELD DATA SOCKET
[Symbol]	SHIELD DATA SOCKET
[Symbol]	VERTICAL PLUGS TO CEILING LAMP TRAYS
[Symbol]	LAMP TRAYS AT FLOOR LEVEL
[Symbol]	FIRE ALARM BELL
[Symbol]	FIRE ALARM BELL
[Symbol]	SMOKE FIRE EXTRACTOR
[Symbol]	CHIMNEY ROOF FIRE EXTRACTOR
[Symbol]	SMOKE EXHAUST FIRE EXTRACTOR
[Symbol]	SMOKE EXHAUST FIRE EXTRACTOR

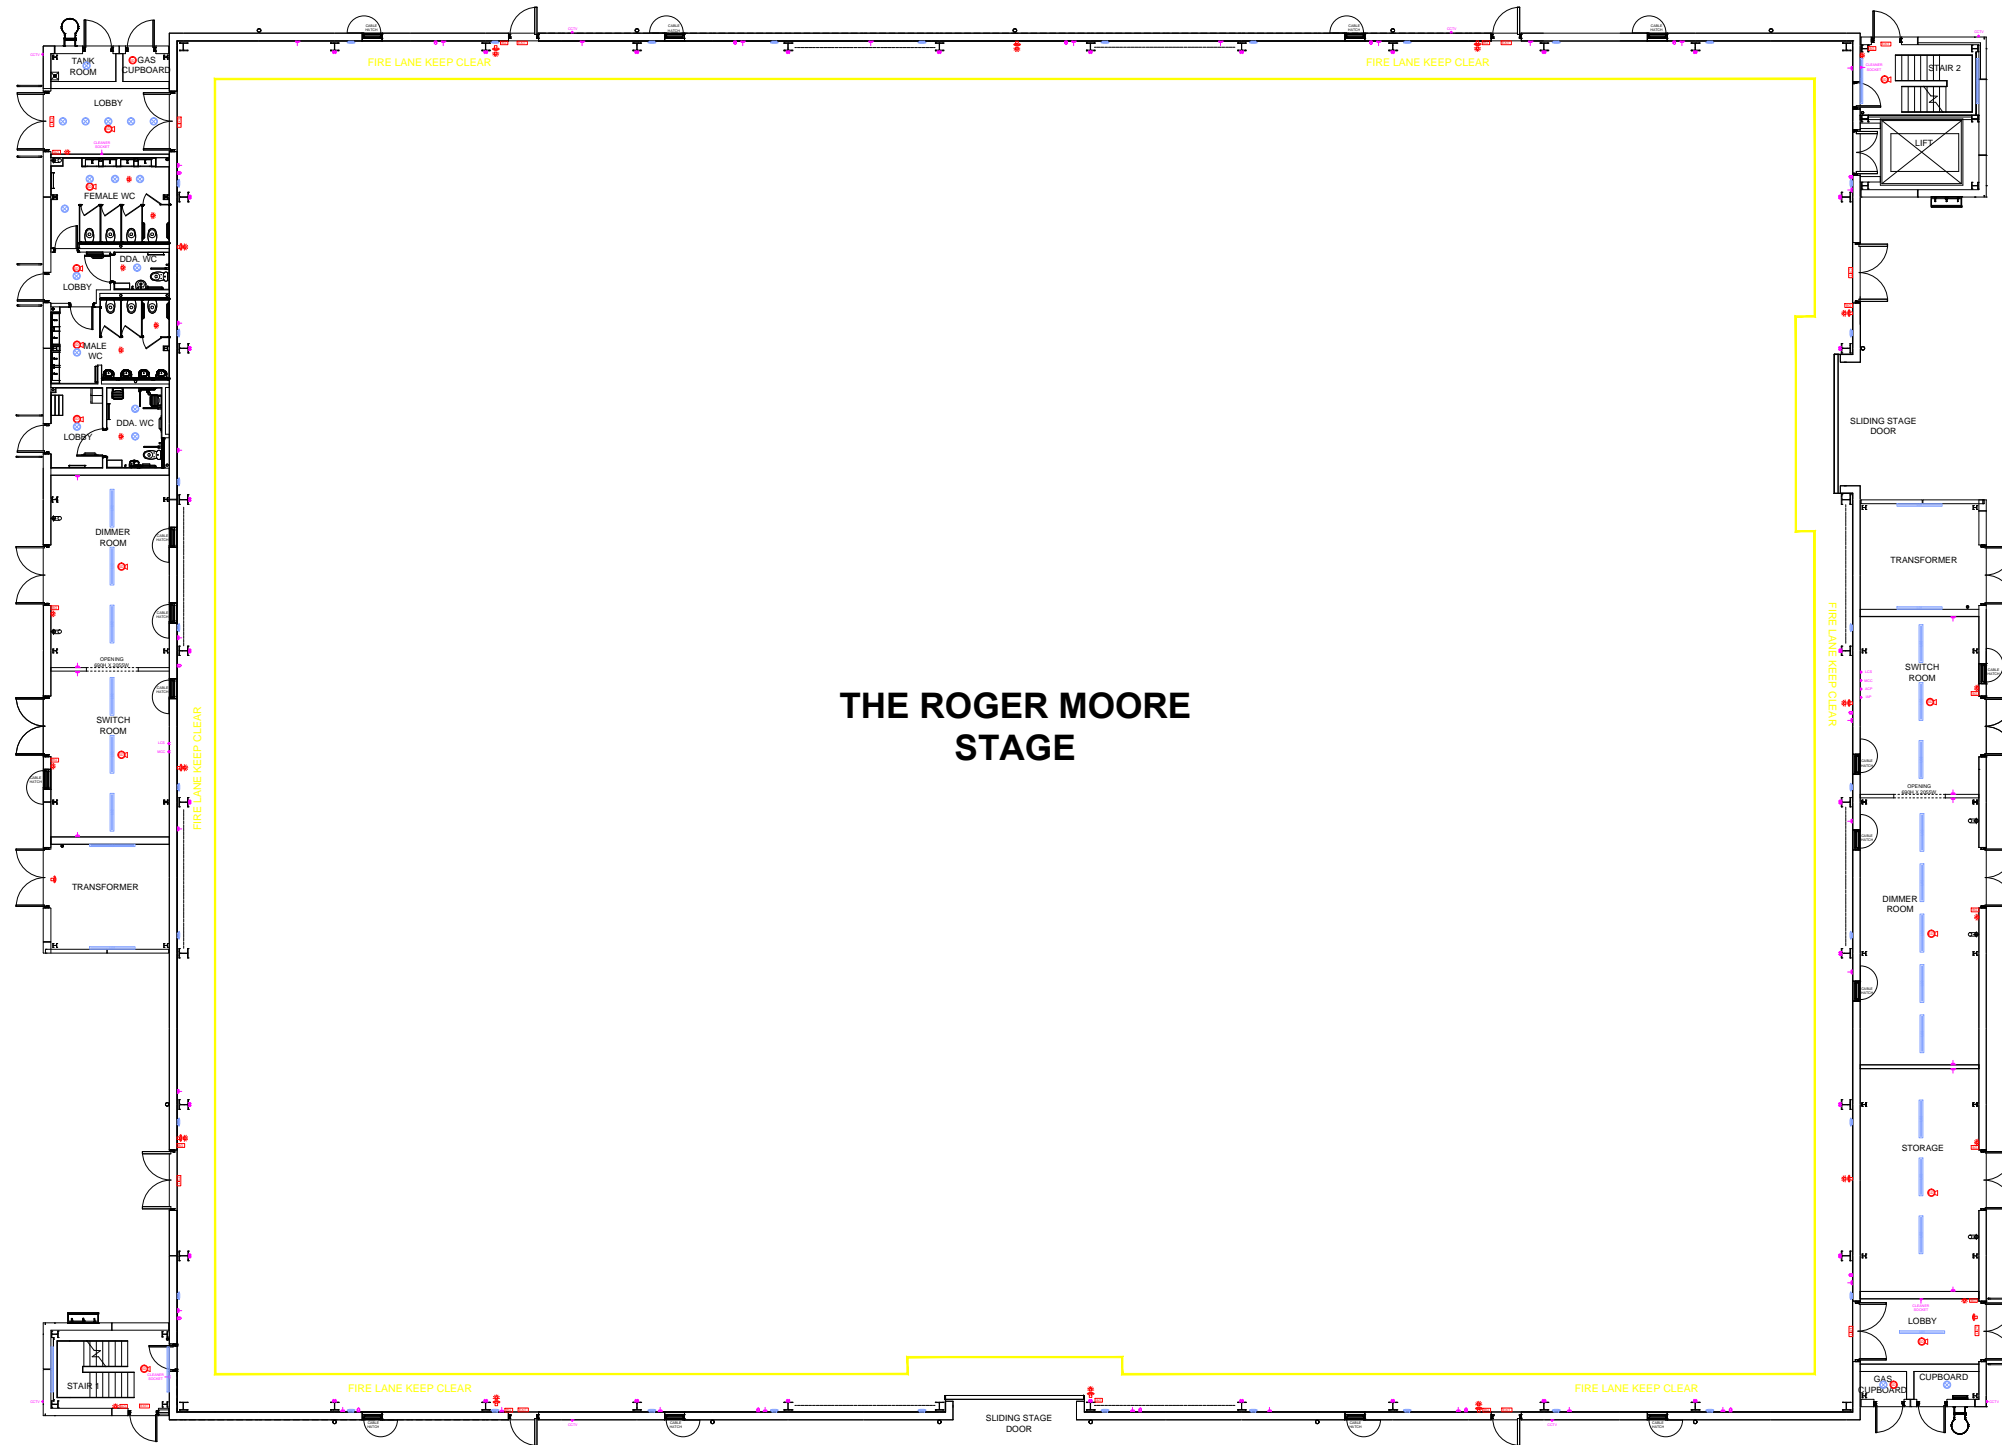

**THE ROGER MOORE
 STAGE**

**THE ROGER MOORE STAGE | EXISTING GROUND FLOOR
 PINEWOOD STUDIOS**



THE ROGER MOORE STAGE DIMENSIONS

STAGE LENGTH	= 218'	[66.5m]
STAGE WIDTH	= 178'	[54.4m]
GROUND FLOOR AREA	= 38,804 ft²	[3616m²]
FFL TO LOWER GANTRY LEVEL	= 12.827m	
FFL TO UPPER GANTRY LEVEL	= 15.615m	

**PROJECT
 MANAGEMENT
 DEPARTMENT**

PROJECT
**PINEWOOD STUDIOS
 THE ROGER MOORE STAGE**

DRAWING TITLE
EXISTING GROUND FLOOR

SCALE	DATE	DRAWN BY
1:300 @ A3	01-10-13	SDM

