


THIS DRAWING IS THE PROPERTY OF PINewood ATLANTA LLC AND MUST NOT BE COPIED OR REPRODUCED IN WHOLE OR IN PART BY ANY METHOD WHATSOEVER, WITHOUT PERMISSION OR THE WRITTEN AUTHORIZATION OF PINewood ATLANTA LLC.

**PINewood ATLANTA STUDIOS
SITE PLAN**

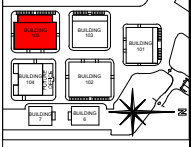

**PINewood ATLANTA BUILDING 105
STAGES 7 & 8 DIMENSIONS**

STAGE 7 LENGTH	= 119'-0" [36.5m]
STAGE 7 WIDTH	= 165' 8" [50.5m]
STAGE 8 LENGTH	= 119'-0" [36.5m]
STAGE 8 WIDTH	= 165' 8" [50.5m]
GROUND FLOOR STAGES AREA	= 40,796 sq' [3,796sqm]
HEIGHT OF GANTRY	= 42' - 11.75" [14m]

LEGEND:

	ELECTRICAL
	EXISTING SINGLE POLE LIGHT SWITCH
	EXISTING JUNCTION BOX
	DOUBLE DUPLEX RECEPTACLE
	50A NEMA 14-50R 250V RECEPTACLE
	FUSED SWITCH RECEPTACLE
	ELECTRICAL CABINET HEATER
	EXISTING SINGLE POLE LIGHT SWITCH
	PLUMBING
	EXTERIOR WALL HYDRANT
	FIRE DETECTION
	EXISTING PULL
	EXISTING STROBE HORN
	EXISTING STROBE
	EXISTING DIRECTIONAL ILLUMINATED EMERGENCY EXIT LIGHT
	EXISTING CDD FIRE EXTINGUISHER
	LIGHTING
	EXISTING WALL MOUNTED HOUSE EMERGENCY LIGHT
	EXISTING UNDERRISE OF CATWALK MOUNTED HOUSE LIGHT
	EXISTING VISUAL STUDIO WARNING LIGHT
	EXISTING WALL MOUNTED HOUSE LIGHT AT CATWALK LEVEL
	EXISTING CATWALK HOUSE LIGHTING


	CATWALK LEVEL
	CATWALK LADDER TO LOWER CATWALK
	MECHANICAL HATCH
	MOUNTED 30' AFF AND CONTROLLED THROUGH LIGHTING CONTROL PANEL LOCATED IN ELECTRICAL ROOM
	CHILL WATER PENETRATIONS
	FIRE EXIT
	ROOF ABOVE

PROJECT MANAGEMENT DEPARTMENT

PROJECT
PINewood ATLANTA STUDIOS
BUILDING 105 STAGES 7 & 8

DRAWING TITLE
EXISTING GROUND FLOOR LEVEL

SCALE	DATE	DRAWN BY
1/32"=1'-0"	FEBRUARY 2015	JLMC

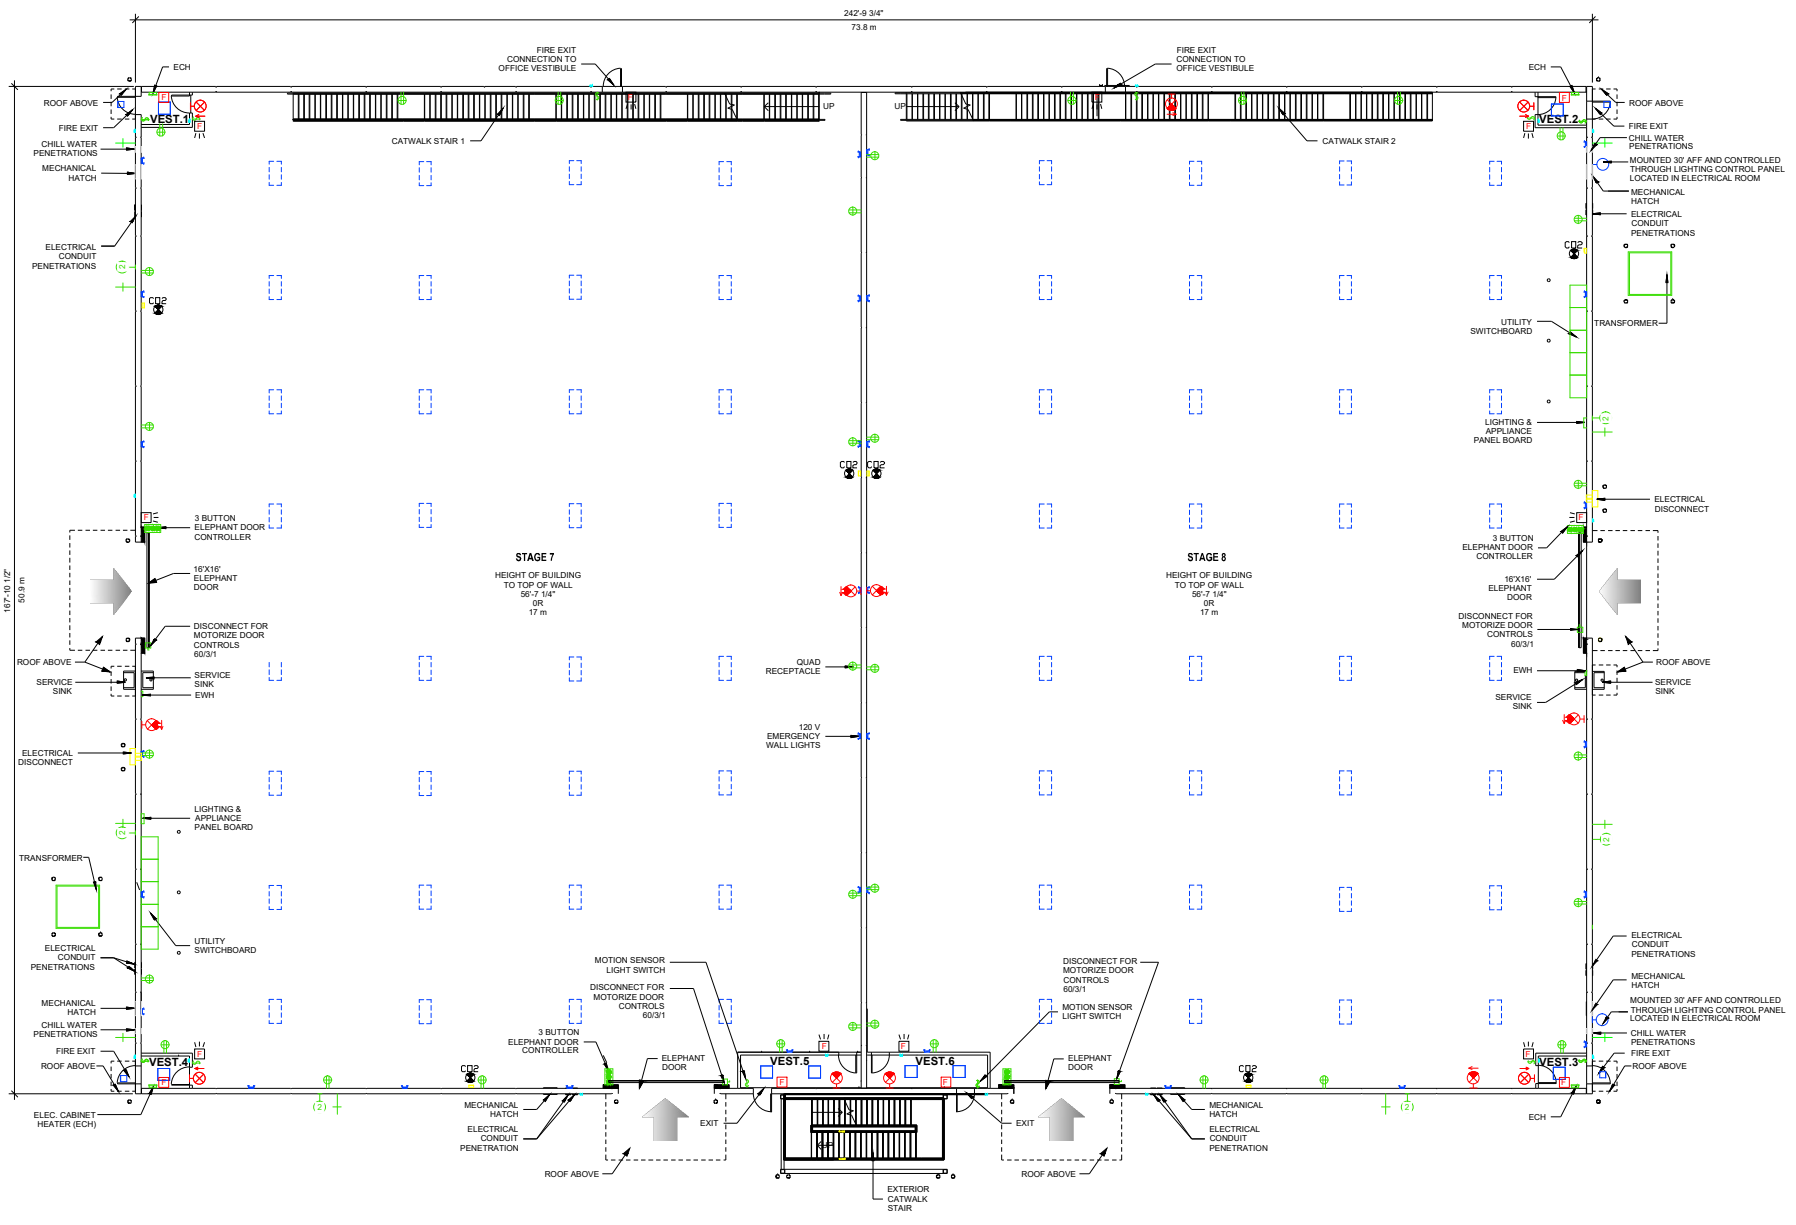

**BUILDING 105 STAGES 7 & 8 | EXISTING GROUND FLOOR LEVEL
PINewood ATLANTA STUDIOS**